

STOW MUNROE FALLS  
HIGH SCHOOL  
3227 GRAHAM ROAD  
STOW, OHIO 44224


### SITE MAP

## DRAWING INDEX

- A-01 EX. DEMO FLOOR PLANS
- A-02 NEW FLOOR PLANS
- A-03 SECTION AND DETAIL PLANS
- E-01 EX. ELECTRICAL PLANS
- E-02 NEW ELECTRICAL PLANS
- H-01 EX. HVAC PLANS
- H-02 NEW HVAC DETAIL PLAN
- PS-01 EX. SPINKLER AND PLUMBING PLANS

## GENERAL NOTES


1. CONTRACTORS SHALL VERIFY ALL DIMENSIONS IN THE FIELD AND SHALL NOTIFY ARCHITECT OF ANY DISCREPANCIES. ALL WOORK REQUIRING MEASURING SHALL BE DONE ACCORDING TO FIGURES ON DRAWINGS AND NOT SCALED FROM DRAWINGS. ARCHITECT WILL FURNISH ANY OTHER DIMENSIONS ON REQUEST.
2. ALL WORK SHALL CONFORM TO ALL PREVAILING CODES, ORDINANCES, AND REQUIREMENTS.
3. CONTRACTORS SHALL OBTAIN ALL PERMITS AND INSPECTIONS REQUIRED FOR CONSTRUCTION AND WILL PAY ALL APPLICABLE FEES.
4. ALL PENETRATIONS OF FIRE RATED WALLS SHALL BE SEALED WITH APPROVED MATERIALS TO THE FULL THICKNESS OF THE CONSTRUCTION ELEMENT.
5. CONTRACTORS SHALL FAMILIARIZE THEMSELVES WITH ACTUAL FIELD CONDITIONS PRIOR TO SUBMITTING BIDS.

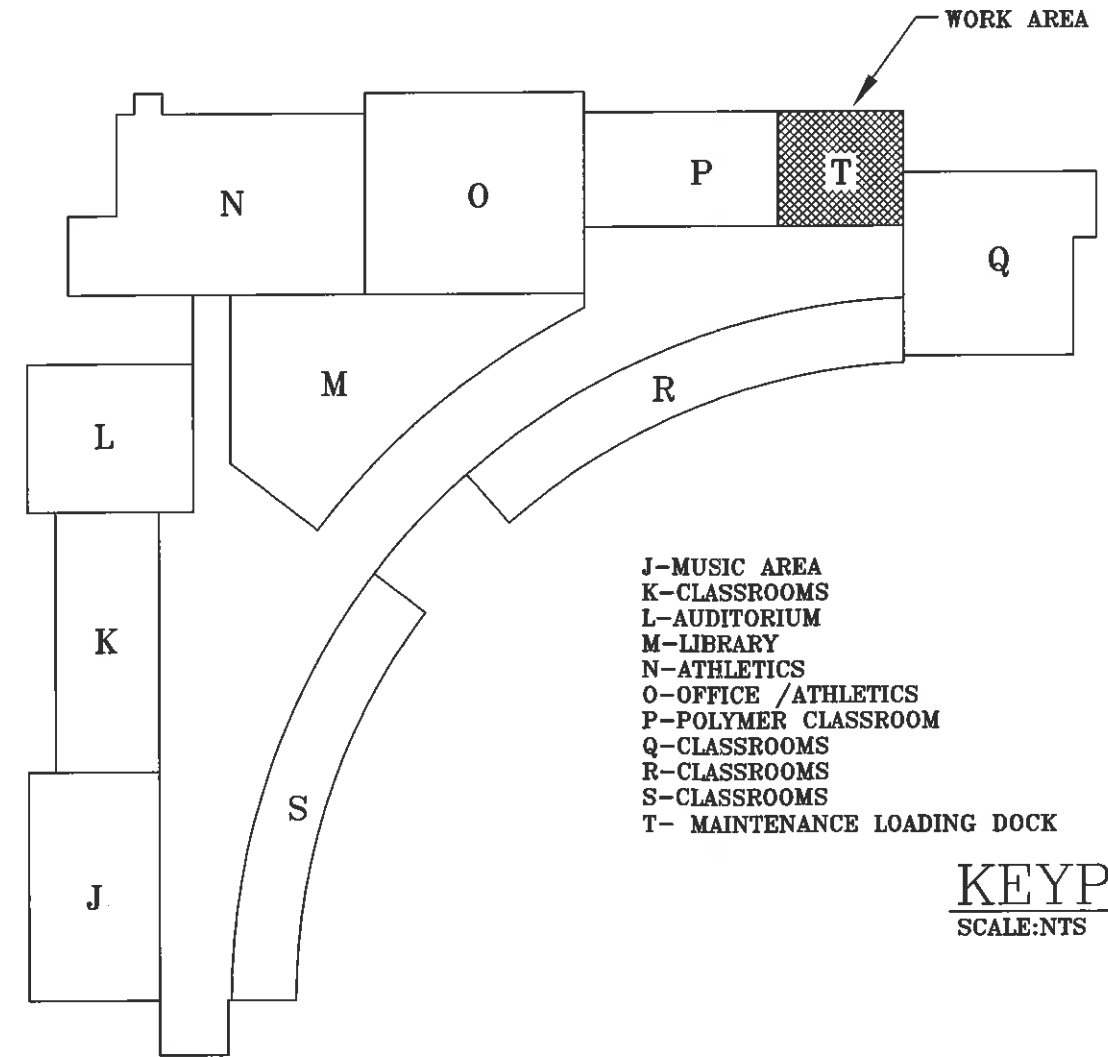


- J-MUSIC AREA
- K-CLASSROOMS
- L-AUDITORIUM
- M-LIBRARY
- N-ATHLETICS
- O-OFFICE /ATHLETICS
- P-POLYMER CLASSROOM
- Q-CLASSROOMS
- R-CLASSROOMS
- S-CLASSROOMS
- T- MAINTENANCE LOADING DOCK


KEYPLAN  
SCALE:NTS



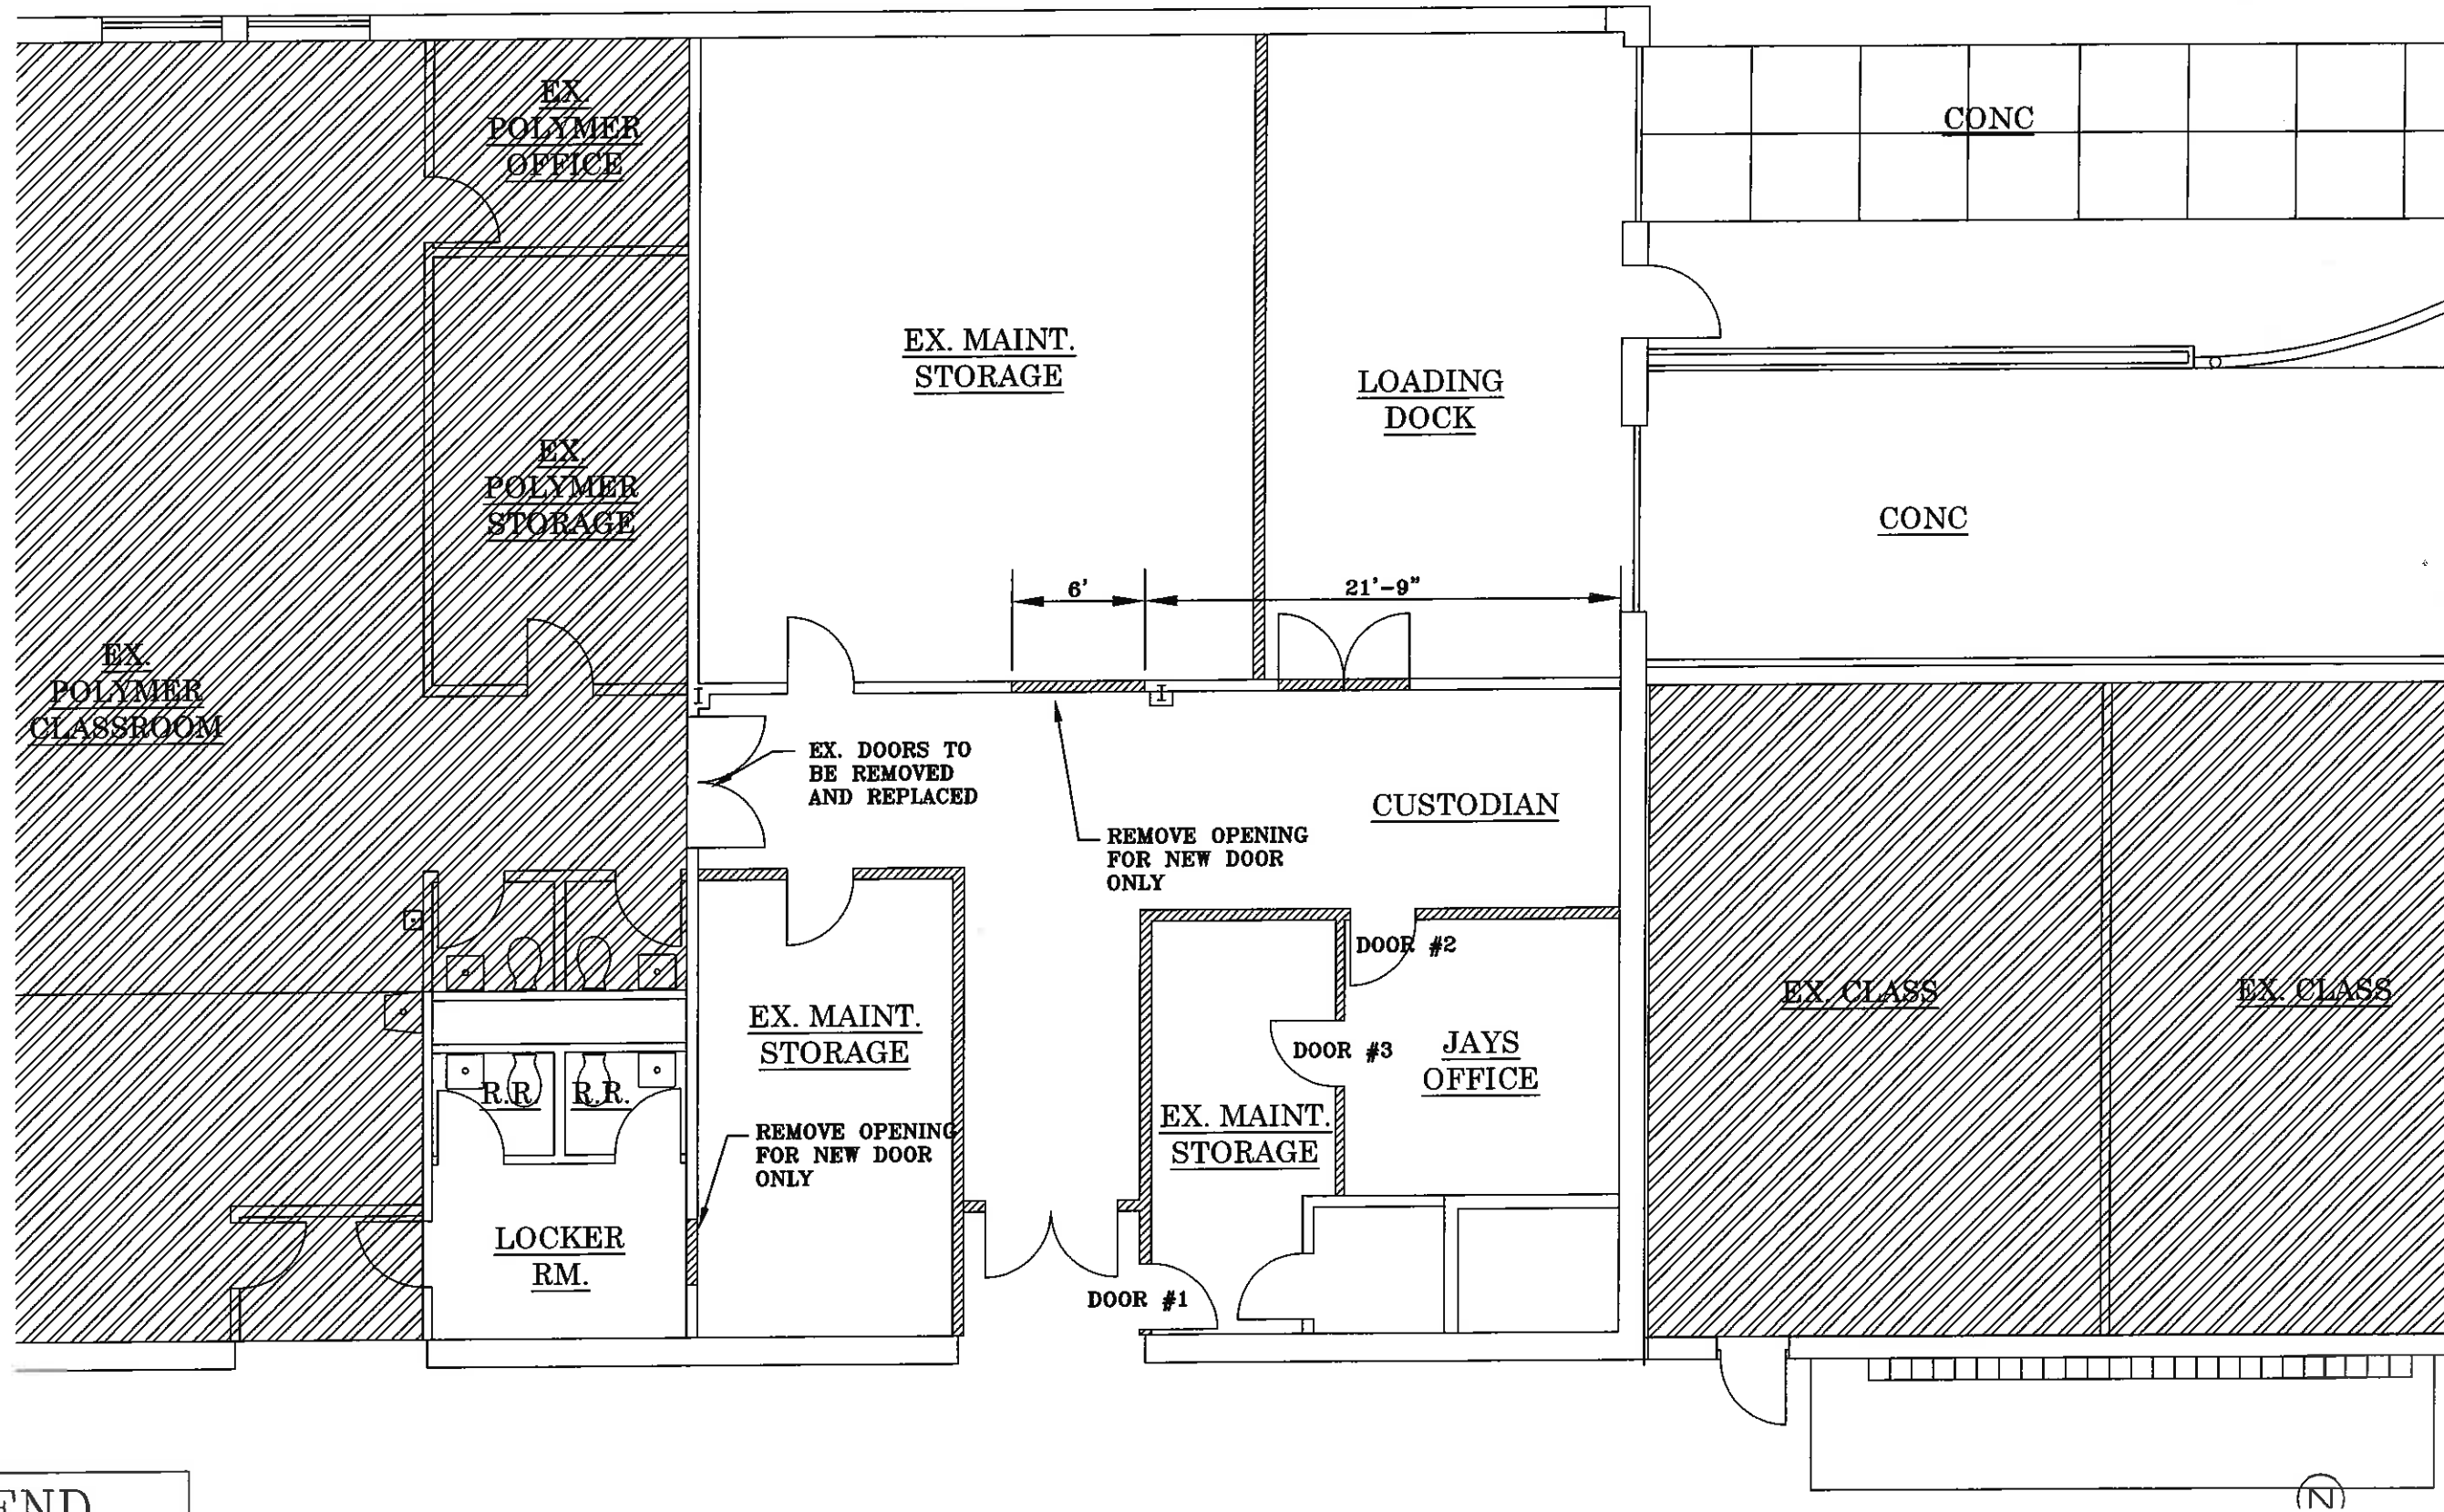

**LEGEND**

 WALLS TO BE REMOVED


 DOORS TO BE REMOVED

HALLWAY




**EX. DEMO FLOOR PLANS**  
 SCALE 1/8"=1'-0"

A-01

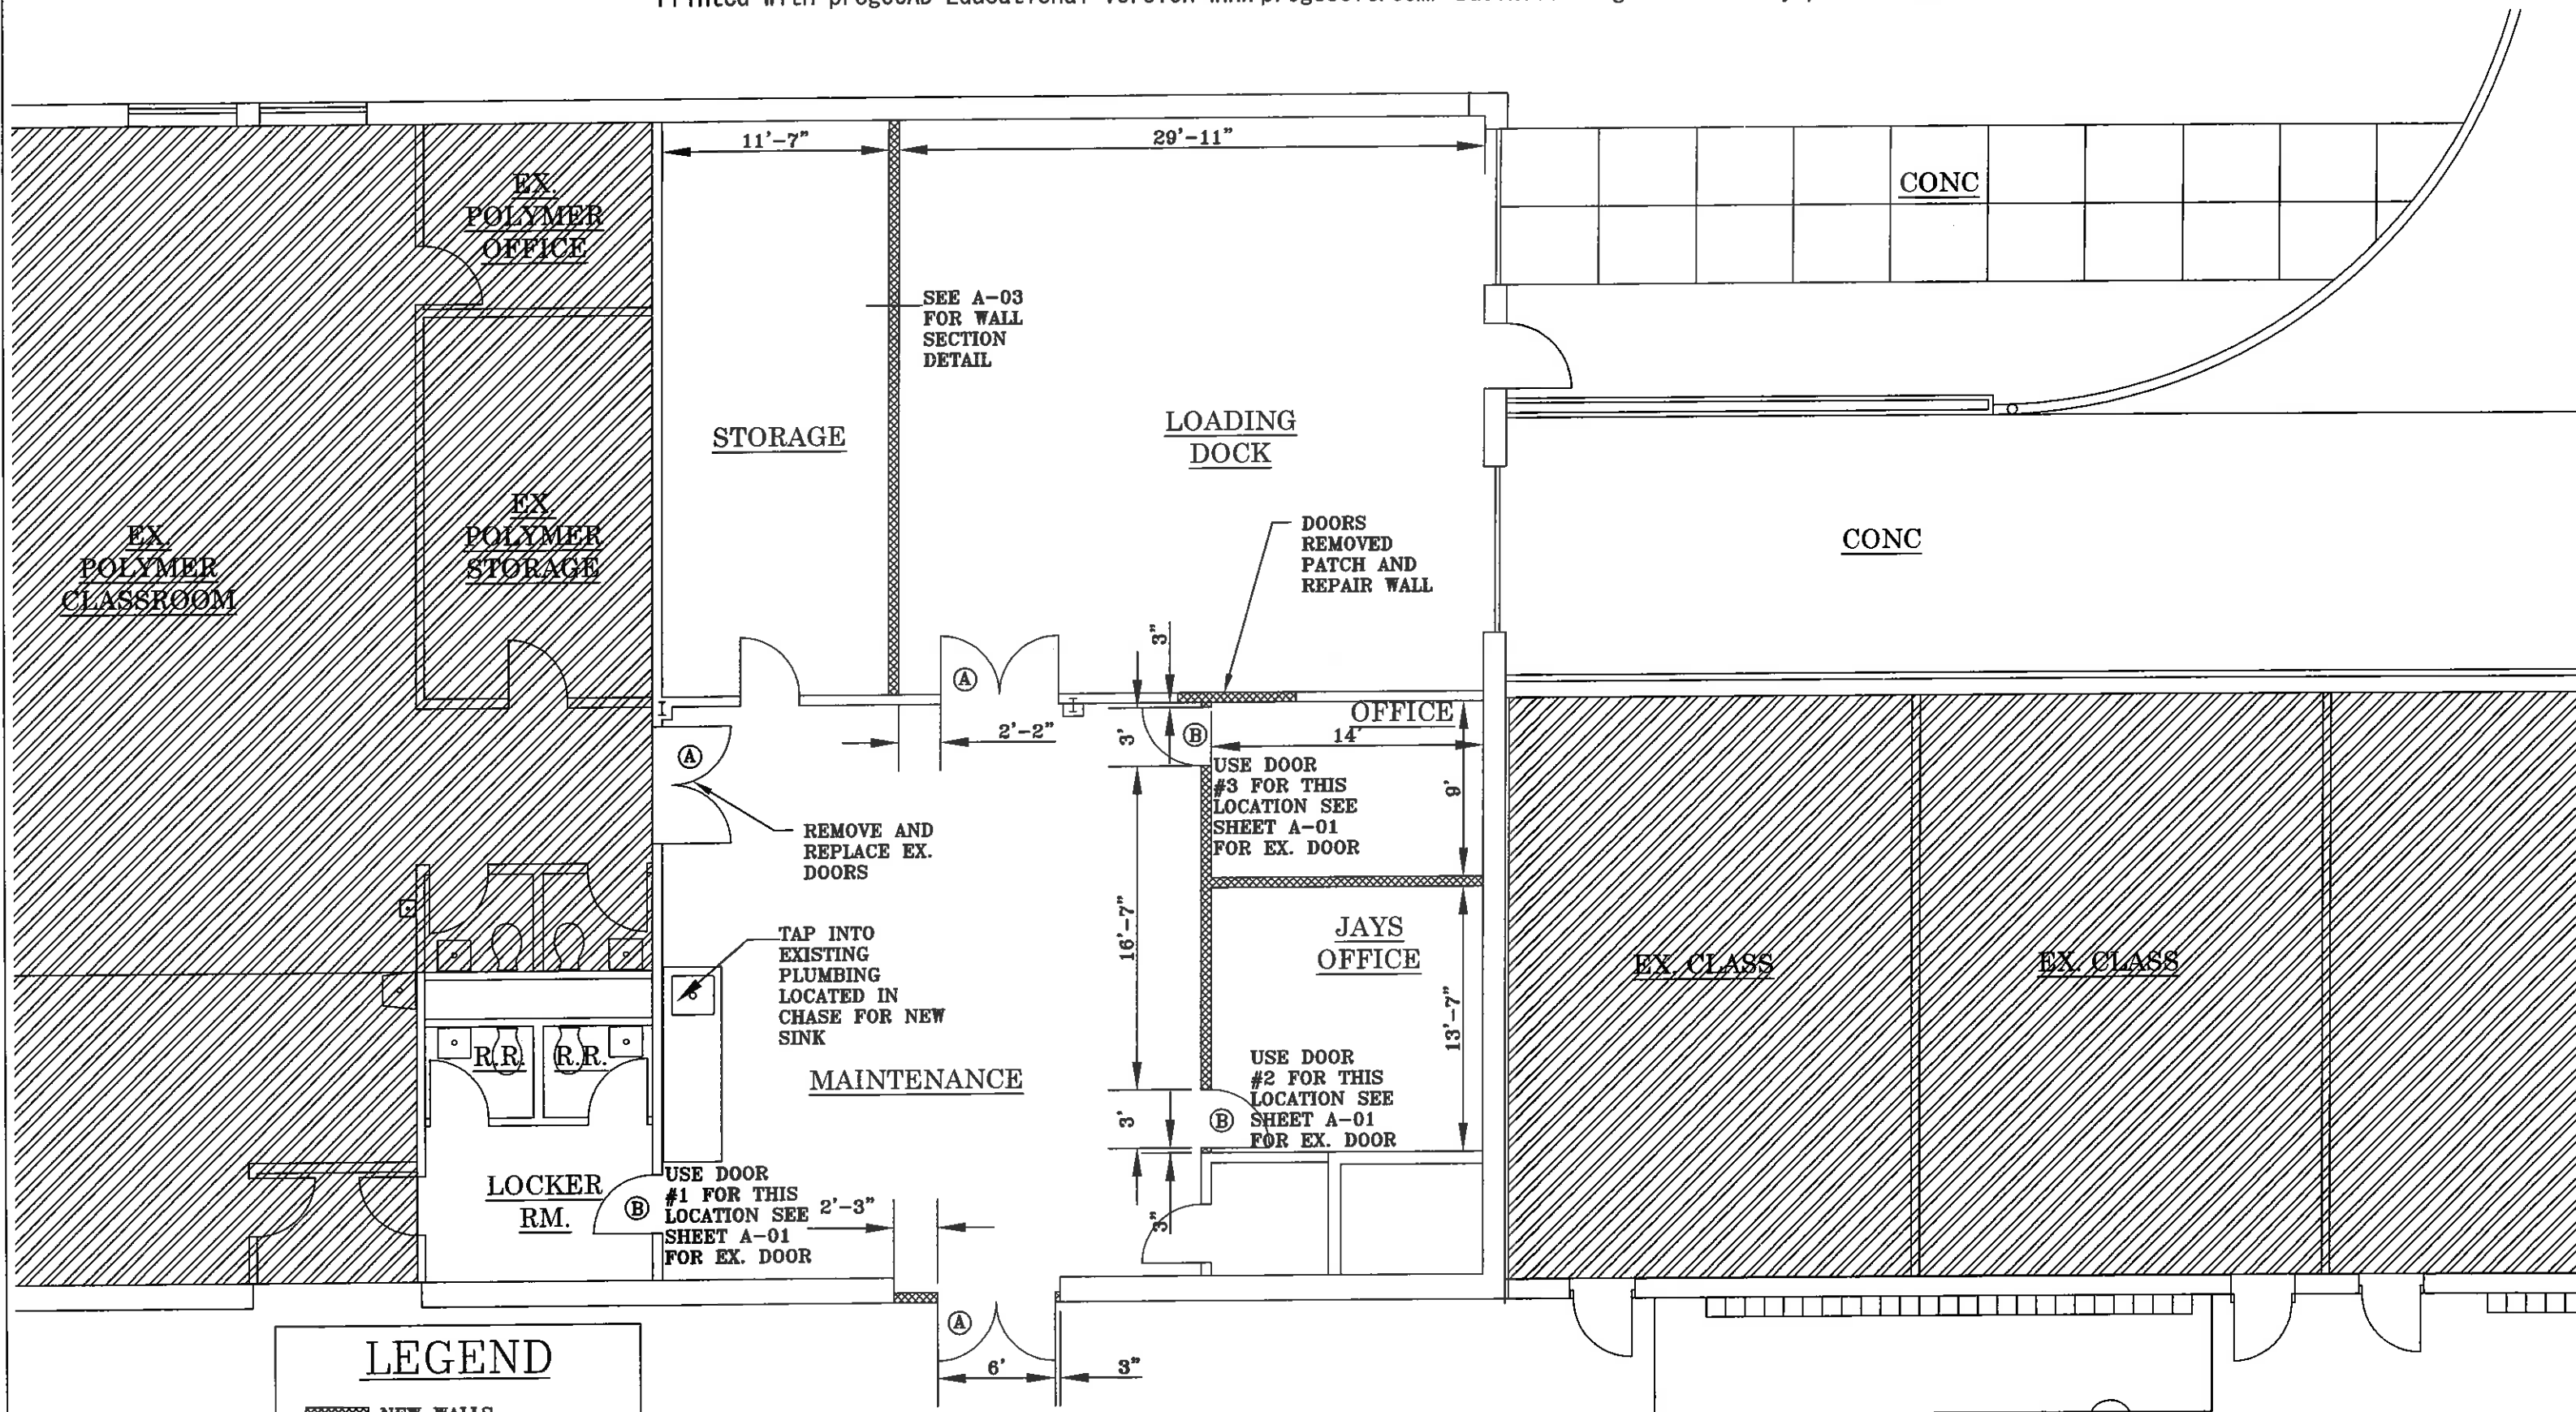


**LEGEND**


-  NEW WALLS
- (A)** SEE ATTACHED CUT SHEETS FOR DOOR DETAILS
- (B)** INSTALL EXISTING SINGLE DOORS THAT ARE BEING RELOCATED FROM DEMO AREAS




**NEW FLOOR PLANS**  
SCALE 1/8"=1'-0"

A-02

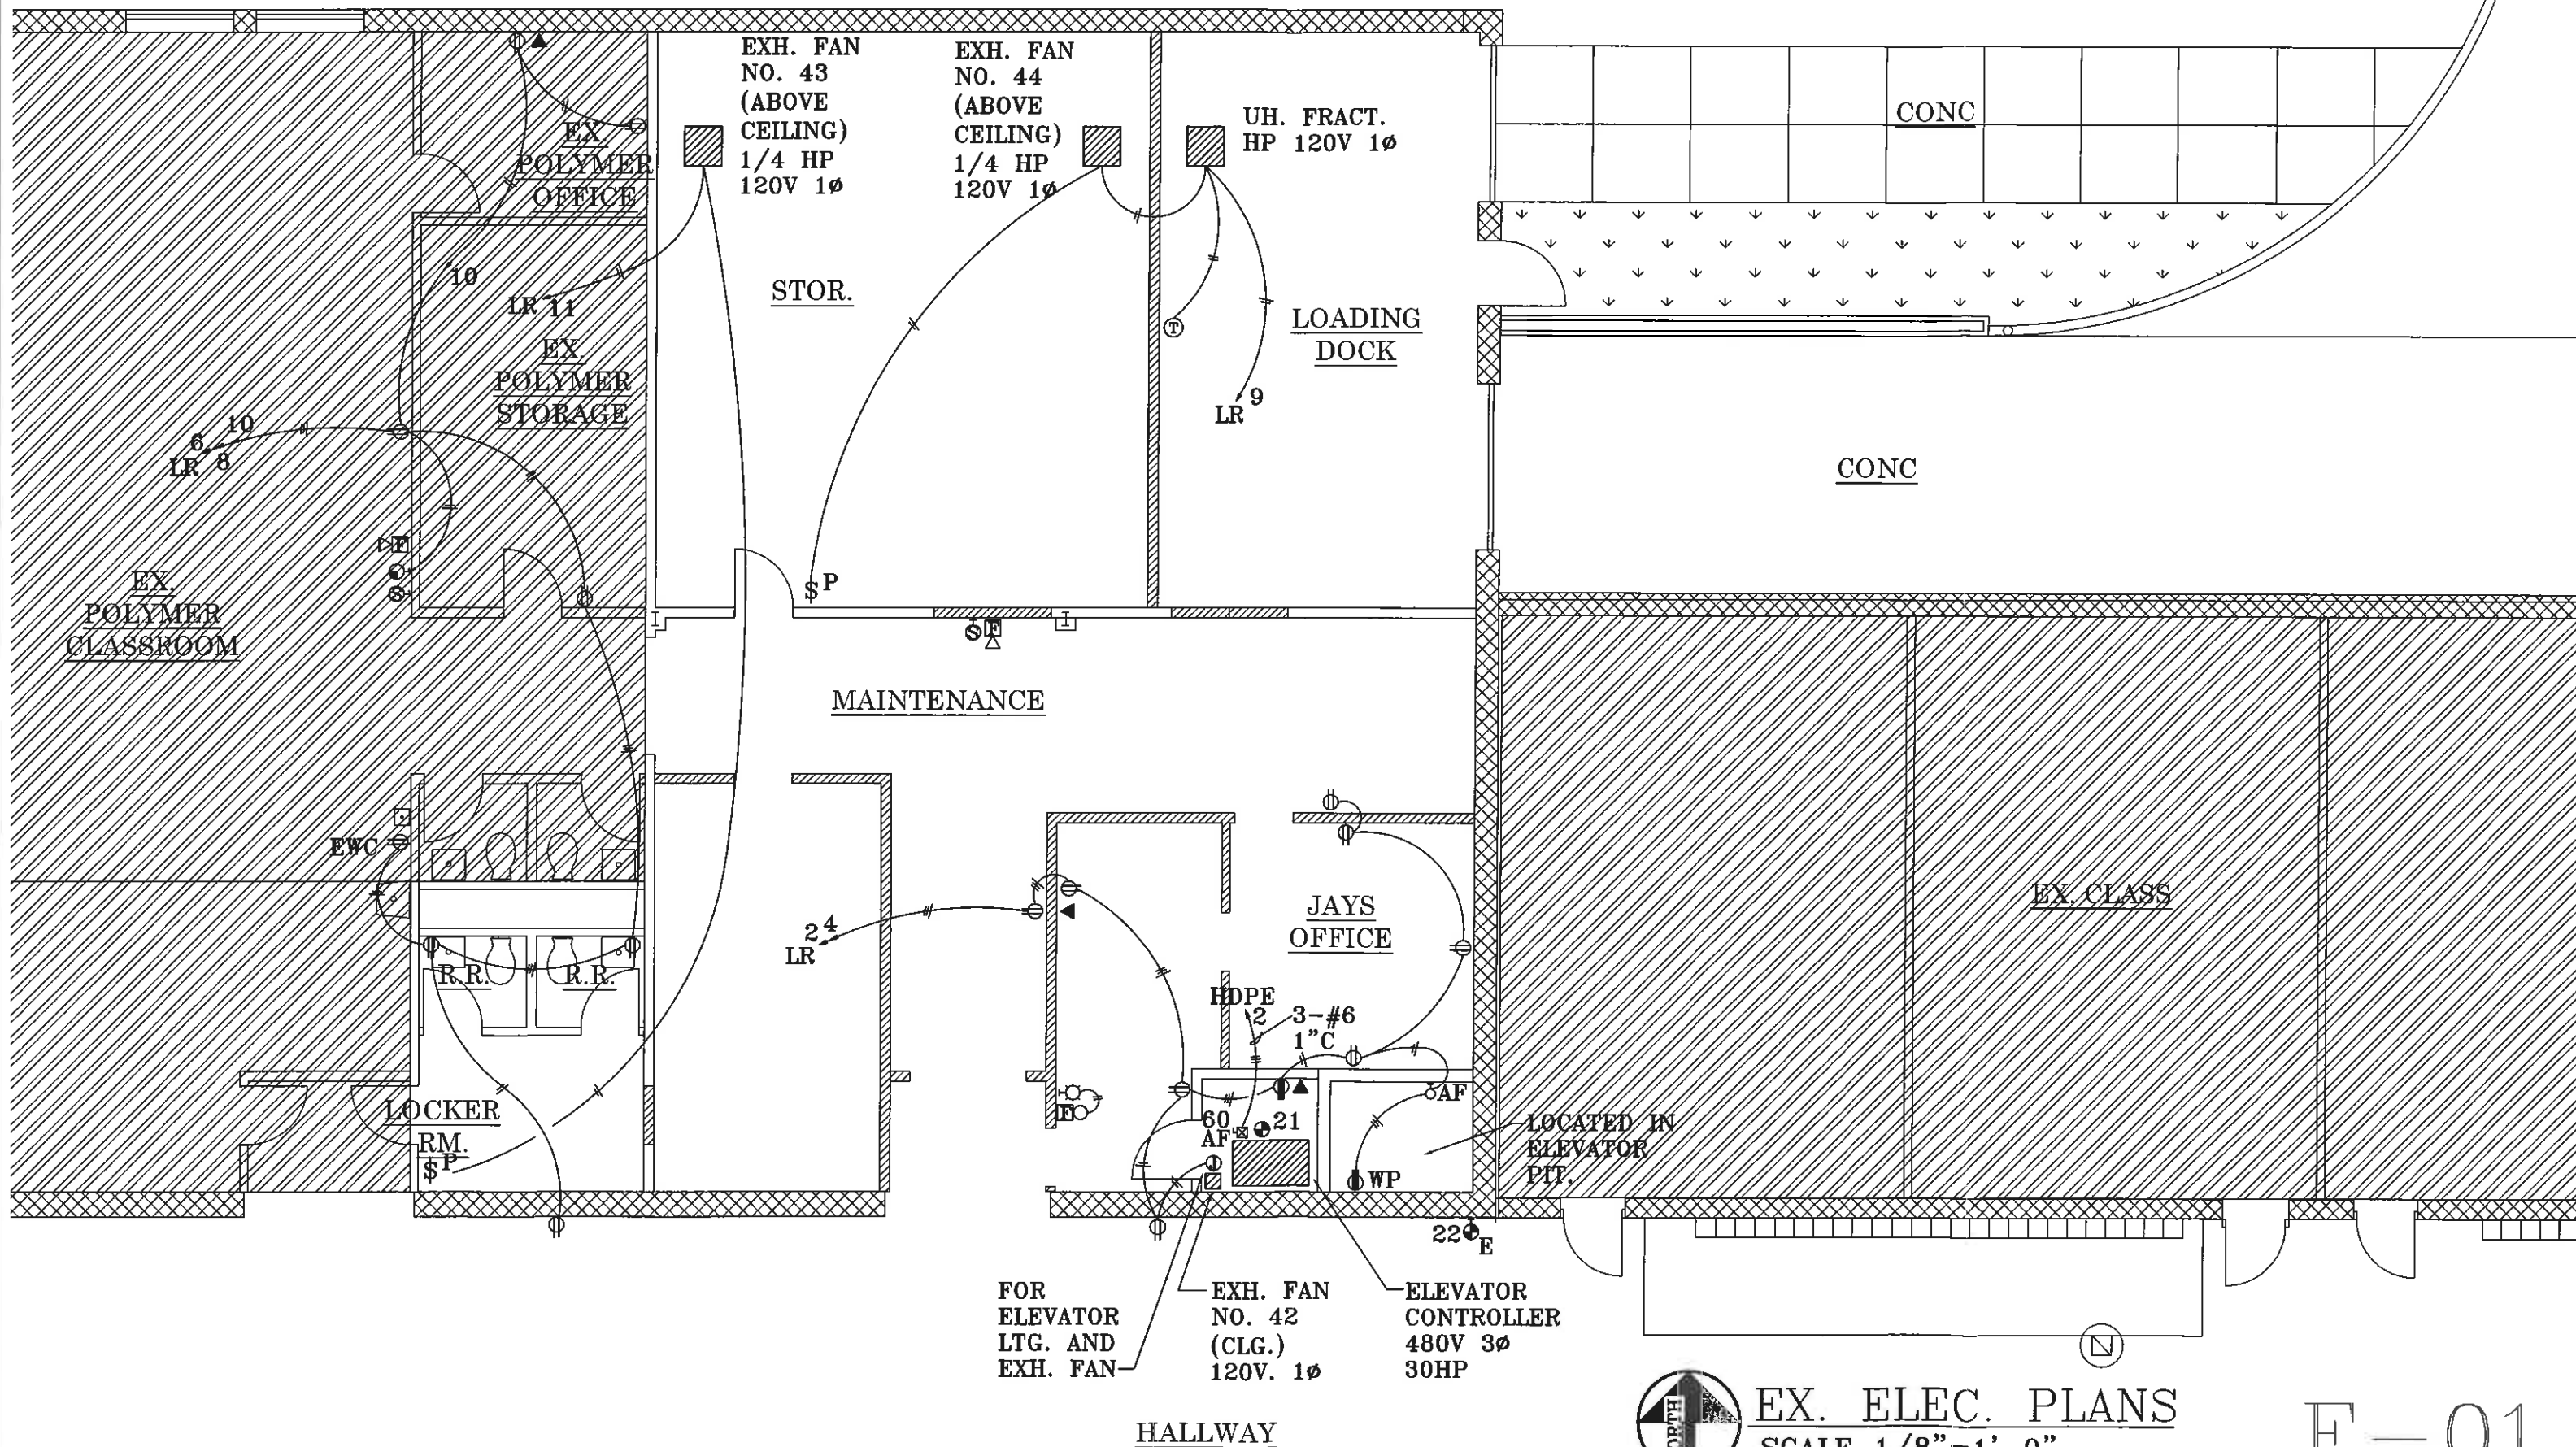


**EX. ELEC. PLANS**  
 SCALE 1/8" = 1'-0"

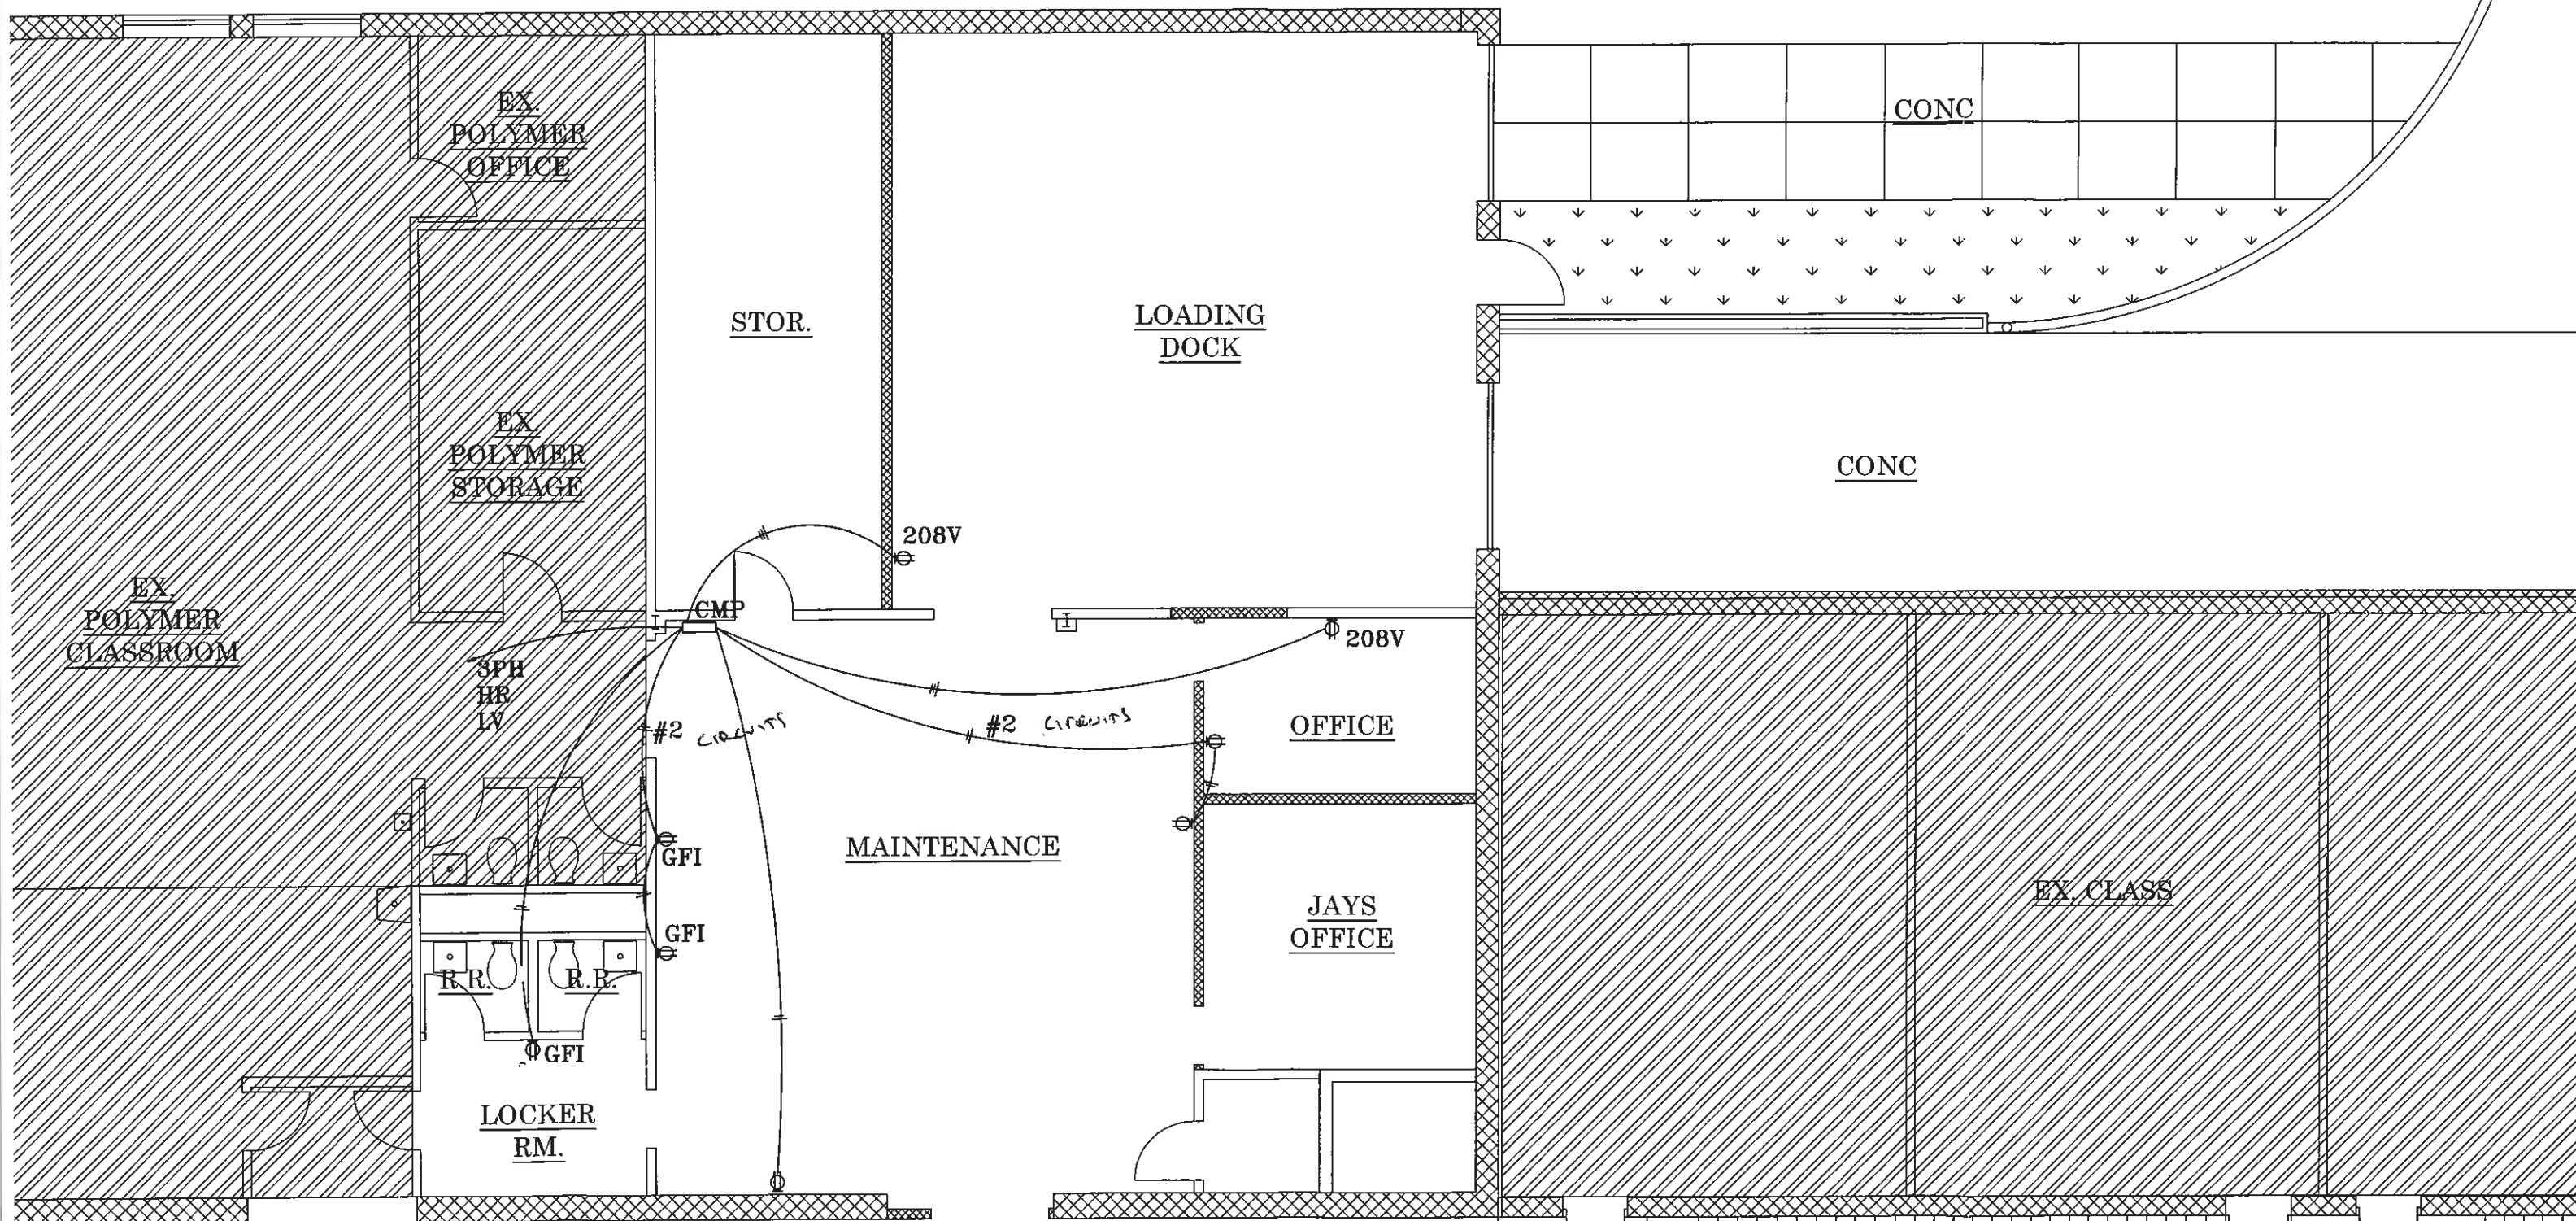


HALLWAY



**NEW ELEC. PLANS**  
 SCALE 1/8"=1'-0"

E-02

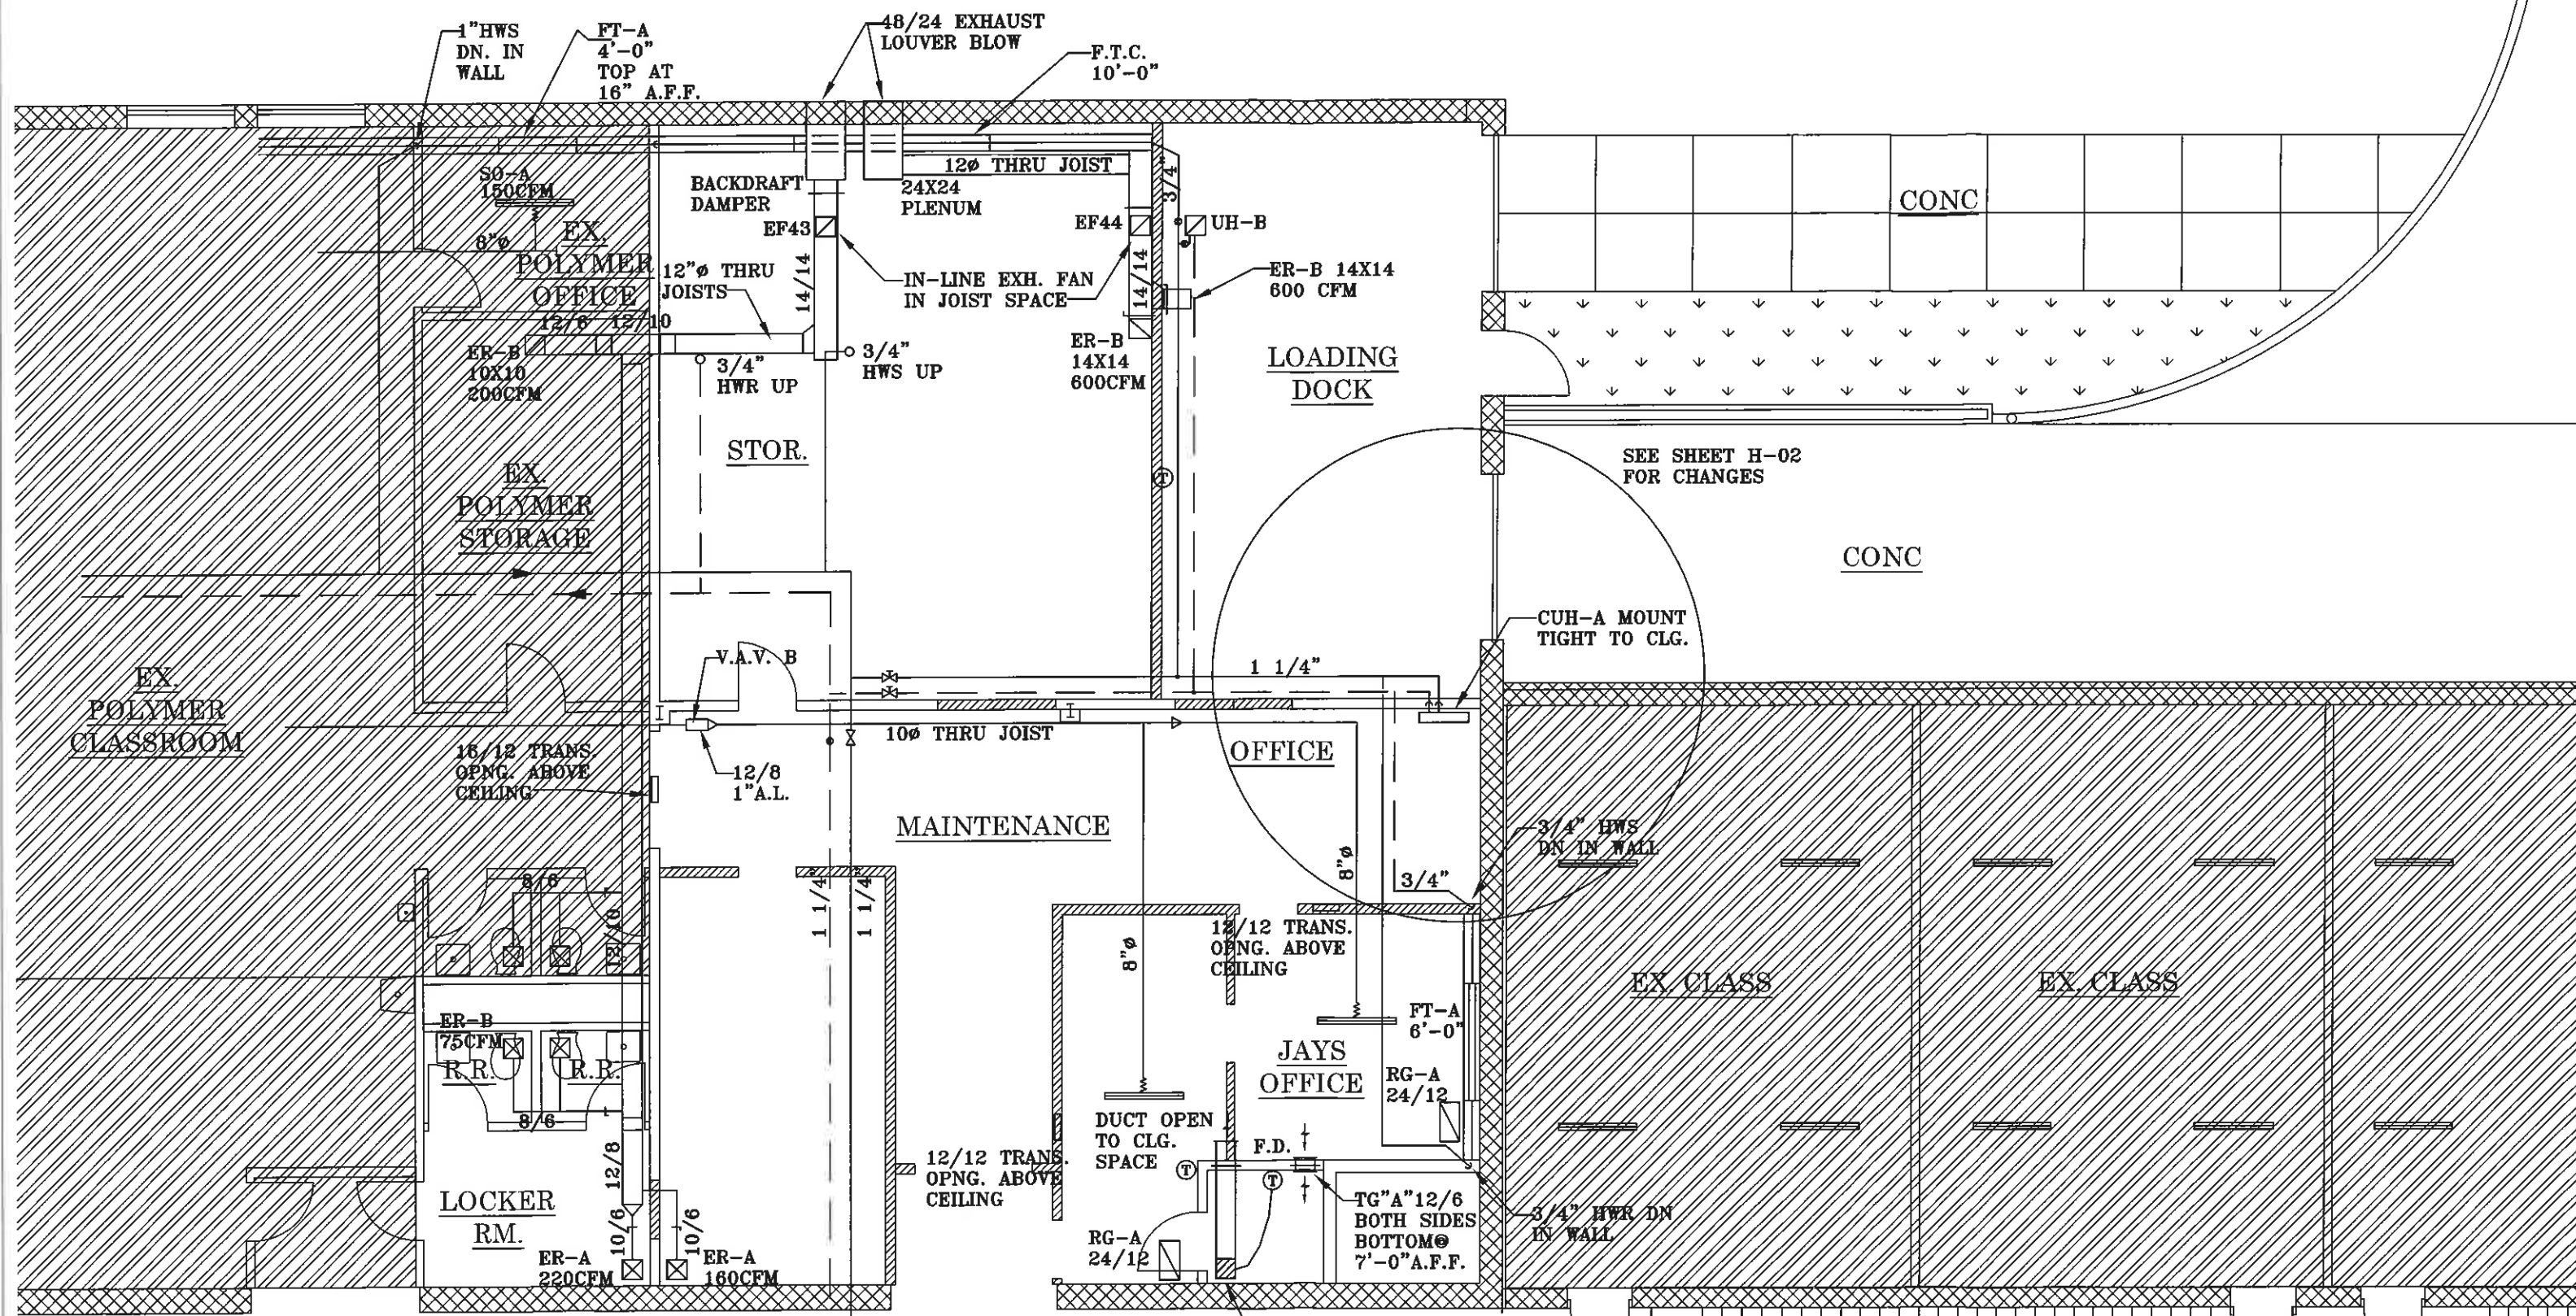


**LEGEND**

☒	SUPPLY DUCT
—	LINEAR DUCT
☐	RETURN AIR DUCT
✕	SHUT OFF VALVE
⊕	THERMOSTAT
∩	VOLUME DAMPER
•	BALANCING VALVE



EX. HVAC PLANS  
 SCALE 1/8" = 1'-0"

H-01

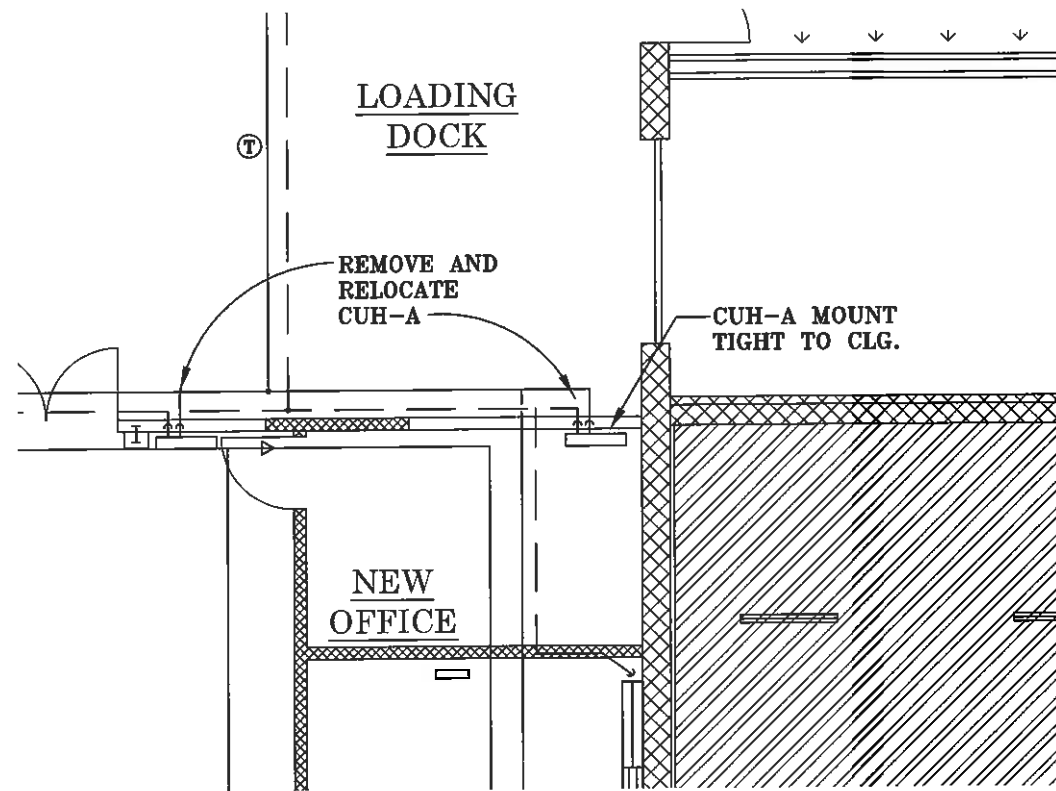

NEW LOCATION DETAIL  
SCALE 1/8"=1'-0"